


**Tipton Fire Station** Tipton, Iowa  
**Mezzanine Level Floor Plan**

DATE: 01.18.10

DRAWING NUMBER: A112

PROJECT NUMBER: 06017

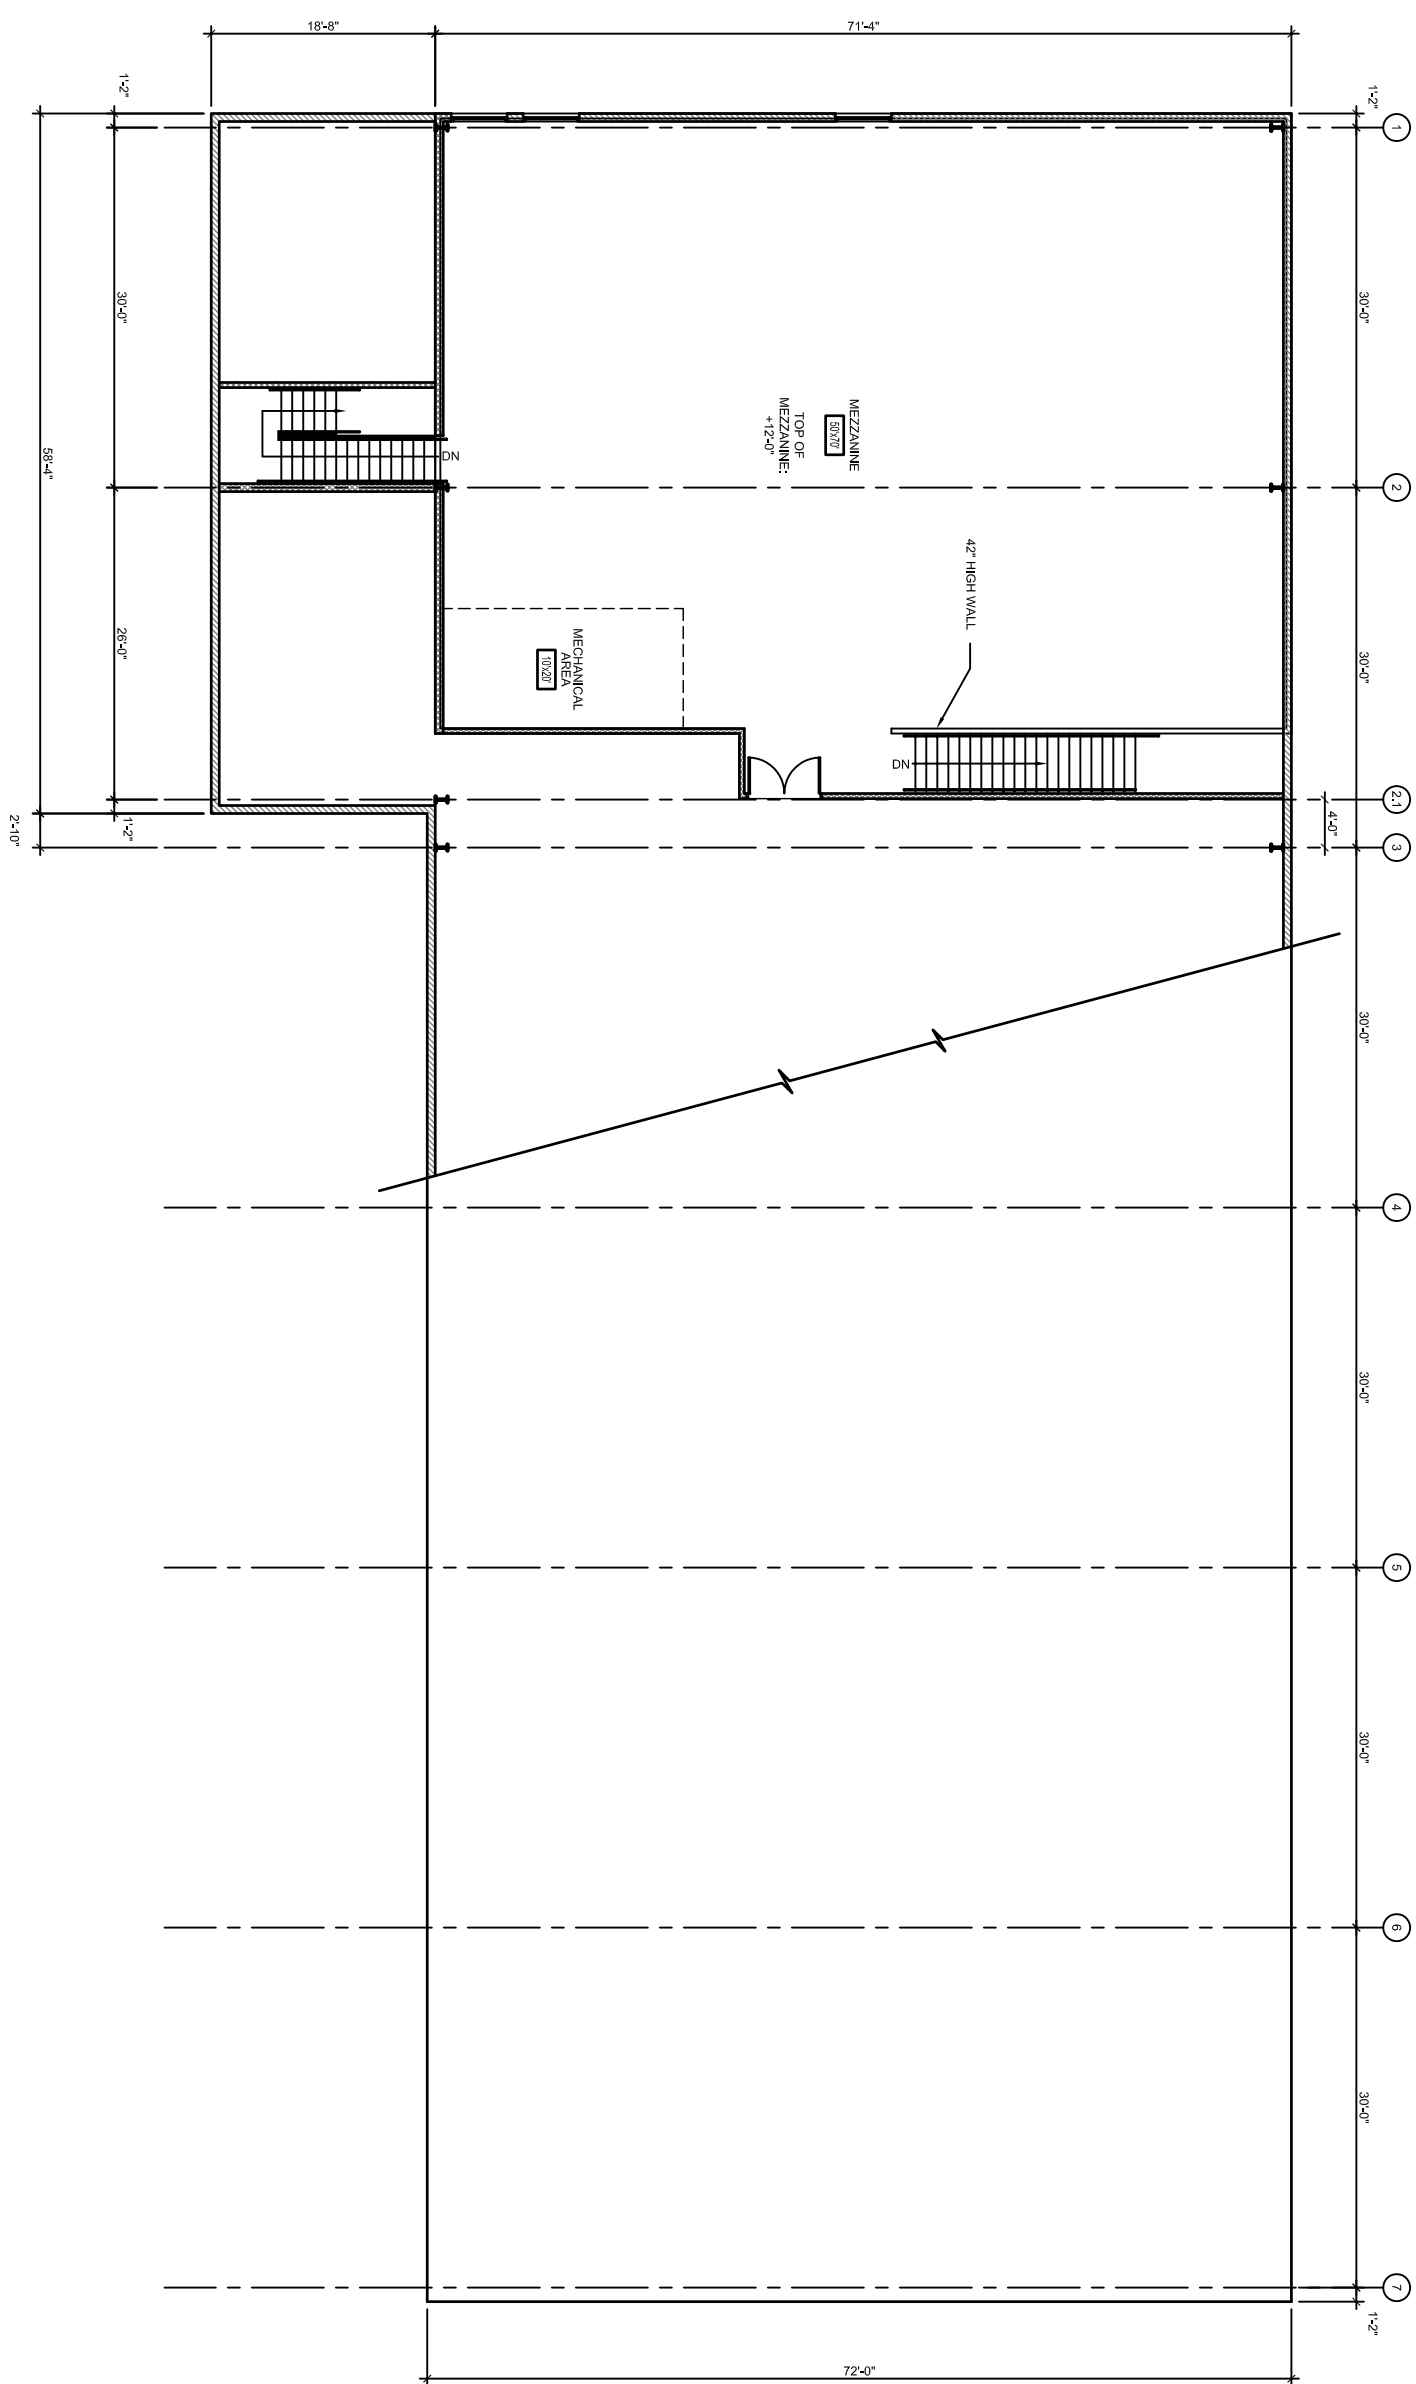

1 MEZZANINE LEVEL FLOOR PLAN  
A112 1/8" = 1'-0"  
AREA: 3,986 S.F.

